


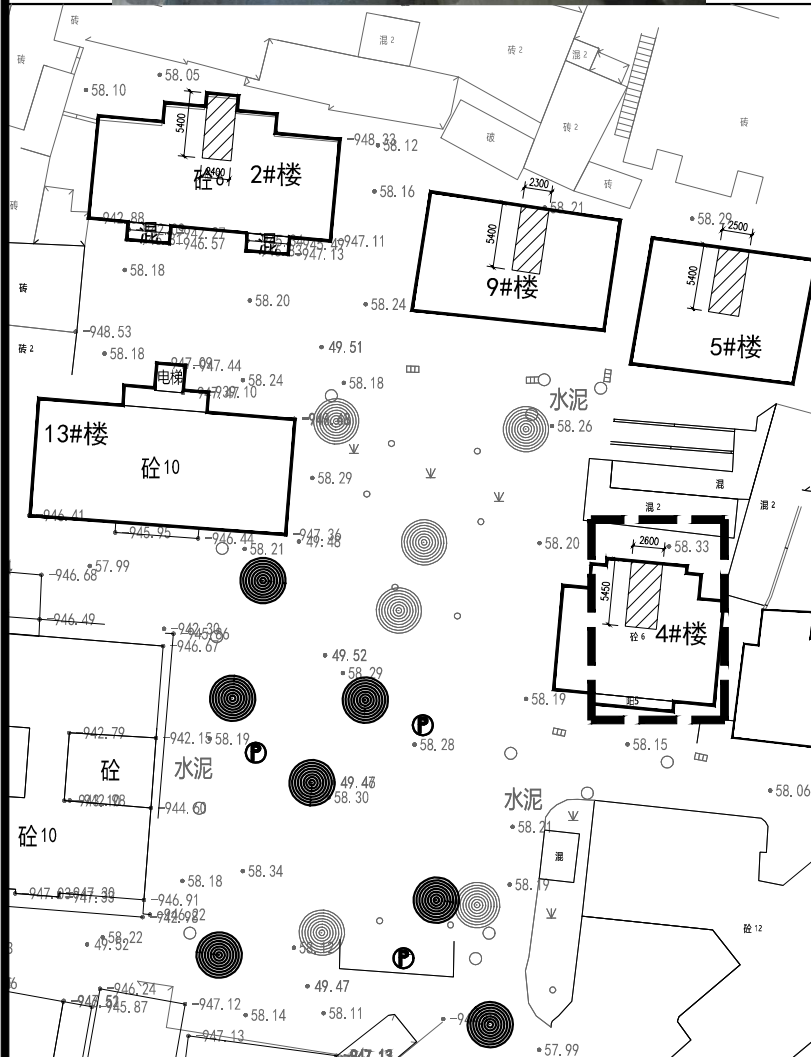

Technical drawing of a staircase platform (Figure 1-10). The drawing shows a rectangular platform with a central staircase. Dimensions are provided in millimeters (mm).

Dimensions:

- Overall width: 2600 mm
- Overall depth: 5400 mm
- Platform depth (excluding stairs): 3000 mm
- Staircase depth: 1150 mm
- Platform width (excluding side walls): 2600 mm
- Staircase width: 1350 mm
- Staircase riser height: 0.900 m
- Staircase tread depth: 0.300 m
- Staircase landing width: 2800 mm

Material and Construction Notes:

- 顶棚: 刷白色无机涂料, 详SM-03, 顶1做法
- 内墙面: 刷白色无机涂料, 踢脚线刷灰色踢脚线无机涂料, 高度100; 做法详SM-03, 墙1做法
- 新增不锈钢扶手 (K7 E4) 15J403-1 ±0.000 (1F)
- 现状扶手 (余同) 保留

Architectural section drawing of a building showing a staircase and floor levels. The drawing includes dimensions for floor levels (19.350, 16.200, 13.050, 9.900, 6.750, 3.600, ±0.000) and horizontal dimensions (1150, 5400, 1250, 2070, 2080, 1250, 5400). It also shows material specifications for walls and stairs.

Material specifications:

- 楼梯间墙面刷白色无机涂料 做法详SM-03, 墙1做法
- 砖砌栏杆刷白色无机涂料 做法详SM-03, 墙1做法
- 100高踢脚线白色无机涂料 做法详SM-03, 墙1做法

Floor levels and dimensions:

- 19.350
- 16.200 6F
- 13.050 5F
- 9.900 @ 6.750 (3-4F)
- 3.600 2F
- ±0.000 1F

Horizontal dimensions:

- 1150
- 5400
- 1250
- 2070
- 2080
- 1250
- 5400

[illegible]

顶棚: 刷白色无机涂料, 详SM-03, 顶1做法

内墙面: 刷白色无机涂料, 踢脚线刷灰色踢脚线无机涂料, 高度100; 做法详SM-03, 墙1做法

Dimensions and Annotations:

- Overall width: 2600
- Overall height: 5400
- Top section height: 1250
- Bottom section height: 3100
- Internal width (excluding side walls): 14.700
- Internal height (excluding top and bottom sections): 3100
- Bottom section width (excluding side walls): 16.200 (6F)
- Bottom section height (excluding side walls): 1050
- Annotations:
 - 现况扶手 (余同) (Existing handrail (same as others))
 - 保留 (Retain)
 - 新增不锈钢扶手 (New stainless steel handrail)
 - 15J403-1
 - K7
 - E4

建设单位 CLIENT	韶关市浈江区城市建设事务中心			
工程名称 PROJECT	浈江区2026年城镇老旧小区改造项目			
子项名称 SUB-TITLE	有色金属大院			
图名 TITLE	有色金属大院#楼架空层改造图			
合同编号 CON. NO.	JK202608022A			
图幅 MAP	A2	版次 EDITION NO.		
专业 DISCIPLINE	建筑	阶段 STAGE	施工图	
日期 DATE	2026. 08	图号 DWG. NO.	22-1-24	

 广东省建科建筑设计研究院有限公司 Guangdong Jianke Architecture Design Institute CO.,Ltd.		
注册行业: (建筑工程) 甲级 证书编号: A144A02355 CONSTRUCTION ENGINEERING GRADE 城乡规划编制(甲级) 证书编号: 自然资甲字21440262 URBAN AND RURAL PLANNING GRADE		
*版权所有, 不得复制、套用或公开。 *本图未经相关部门批准及施工图审查通过, 不得用于施工。		
说明 NOTES		
会签栏 COORDINATION		
建筑 ARCHI.	结构 STRUCT.	
给排水 PLUMBING	电气 ELEC.	
通风空调 HVAC	节能 SAVING	
基坑支护 FOUND. PIT	规划 PLANNING	
签名栏 DESIGNERS		
设计总负责 PROJECT DIRECTOR	冯维莹	
审 定 APPROVED BY	李振华	
审 核 REVIEWED BY	冯维莹	
专业负责 ENGINEER IN CHARGE	向 阳	
校 对 CHECKED BY	孙嘉颖	
设 计 DESIGNED BY	向 阳	
注册师签章 REGISTERED ENGINEER SIGNATURE		
单位出图章 COMPANY SEAL		